



Università degli Studi "Gabriele d'Annunzio"
- sede di Chieti

Responsabile Unico Procedimento
Arch. Giancarlo Laorenza

Via dei Vestini, 31
66100 Chieti (CH)
Tel: +39 0871.3551

Progetto Architettonico

Capogruppo:

Timbro e Firma

**Peia Associati s.r.l.**

Arch. Giampiero Peia

Via Cadolini, 30
20137 Milano (MI)
Tel: +39 02 6598647
Fax: +39 02 36554984
e-mail: info@peiaassociati.it

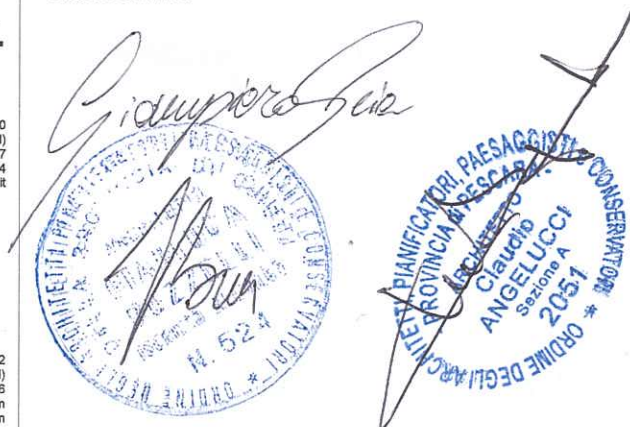
con:

Arch. Gianluca Buzzelli

Arch. Claudio Angelucci



Via della Pace, 42
66026 Ortona (CH)
Tel: +39 347 1349736
e-mail: gianluca.buzzelli@protonmail.com
e-mail: claudioangelucci@protonmail.com



Strutture ed Antincendio

VE.MA. PROGETTI s.r.l.s.

Timbro e Firma



Ing. Domenico Masciandaro

Via Tiburtina Valeria, 132
65128 Pescara (PE)
Tel: +39 331-4198523
e-mail: strutture@vemaprogetti.com

Impianti Meccanici ed Elettrici

TEKSER s.r.l.

Timbro e Firma



Ing. Guido Davoglio

Via E. Caviglia, 3/a
20139 Milano (MI)
Tel: +39 02 5523 0766
e-mail: info@tekser.it



Acustica e impatto ambientale

Ing. Valentina Aceto

Timbro e Firma

Via Austria, n. 6
87036 Rende (CS)
Tel: +39 940 1400199
e-mail: ing.valentinaceto@gmail.com

Oggetto

PERMESSO DI COSTRUIRE

REALIZZAZIONE NUOVO EDIFICIO SEGRETERIE STUDENTI
CAMPUS CHIETI E BAR/PUNTO RISTORO

Chieti (CH)

Soggetto elaborati:

N. Tavola:

Elaborato grafico L. 13/1989 - Superamento delle barriere
architettoniche

E-ACC_01

Disegnatore:

Controllo:

Aggiornamento

Disegno:

F.B.

G.B.

n°. 01

2

Data:

Approvato:

Aggiorn.

Scala:

Formato:

26/06/2021

08/07/2021

varie

A1+

This architectural floor plan illustrates the layout of the first floor of the 'House of the Future'. The plan is rectangular, measuring 240 units in width and 48 units in depth. Key features include a large central circular area containing a complex arrangement of lines and shapes, possibly representing a garden or a large open space. To the left of this circle is a large rectangular area with a smaller square inset, labeled '205'. Above the circle is a rectangular area labeled '240'. To the right of the circle is a rectangular area labeled '48'. The plan also shows various smaller rectangular areas, some with internal details like windows or doors, and a small square area in the bottom right corner labeled '86'. The overall design is modern and minimalist, with clean lines and a focus on geometric shapes.

Technical drawing of a kitchen layout. The drawing shows a sink area with a width of 48 and a depth of 24. A stove is located below the sink. A central island is shown with a width of 38 and a depth of 43. The island has a curved end. The overall dimensions of the kitchen area are 204 in width and 10 in depth. The drawing is labeled with dimensions in inches.

[illegible]

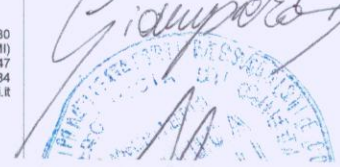
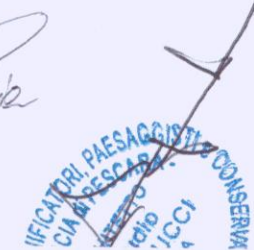
LEGENDA

a_nuove segreterie
Campus Universitario
Chieiti

b_sistemazione esterna
da realizzare in un
successivo lotto di
intervento

This architectural floor plan illustrates a building layout with a red fire alarm system overlay. The system consists of a network of red lines representing the alarm circuit, which includes a central control unit (marked with a red circle) and various components such as smoke detectors (small red circles), manual call points (red squares), and sounders (red circles with a bell icon). The plan also shows room layouts, including corridors, stairs, and various functional areas like a kitchen, dining area, and lounge. The red lines are strategically placed to ensure coverage of all areas, with some lines running along the perimeter and others branching out to specific rooms and corridors.

Piano primo
scala 1:200

Comittente Ud'A Università degli Studi "G. d'Annunzio" Università degli Studi "G. d'Annunzio" Responsabile Unico Procedimento Arch. Giancarlo Laurenza Via dei Vestini, 31 66100 Chieti (CH) Tel. +39 0871.3551		
Progetto Architettonico PEIA	Capogruppo: Peia Associati s.r.l. Arch. Gianpiro Peia Via Canale, 30 20137 Milano, Italy Tel. +39 02 5555555 Fax. +39 02 5555554 email: info@peiaassociati.it	Timbro e Firma <i>Gianpiro Peia</i>  
con:		
COMUNE DI CHIETI III SETTORE ALLEGATO AL PERMESSO DI COSTRUIRE N° <u>21</u> Prot. <u>63299</u> del <u>15</u> OTT. 2021 IL DIRIGENTE DEL SETTORE Arch. Valeria Magliotti IL RESPONSABILE TECNICO Geom. G. Di Giambattista <i>[Signature]</i>		